

OWNER
MINNESOTA SPORTS FACILITIES AUTHORITY
900 SOUTH 5th STREET, MINNEAPOLIS, MN 55415

OWNER
MINNESOTA VIKINGS FOOTBALL LLC
8500 VIKING DR., EDEN PRAIRIE, MN 55344

ARCHITECT / INTERIORS / BRANDING
HKS, INC.
3601 ST. PAUL ST., SUITE 100, DALLAS, TX 75201

ASSOCIATE ARCHITECT - SKIN
STUDIO FIVE ARCHITECTS
322 FIRST AVE. N. SUITE 600, MINNEAPOLIS, MN 55401

ASSOCIATE ARCHITECT - INTERIORS
STUDIO HIVE
901 NORTH 3rd ST., SUITE 228, MINNEAPOLIS, MN 55401

MEP / TECHNOLOGY / LIGHTING
H&E ENGINEERS, INC.
10555 WEST 43rd AVE., WHEAT RIDGE, CO 80033

STRUCTURAL ENGINEER
THORNTON TOMASETTI
12750 MERIT DR., SUITE 750, LB-7, DALLAS, TX 75252

CIVIL ENGINEER
EVS, INC.
10325 VALLEY VIEW, SUITE 140, EDEN PRAIRIE, MN 55344

LANDSCAPE ARCHITECT
OSLUND AND ASSOCIATES
115 WASHINGTON AVE. N., MINNEAPOLIS, MN 55401

AUDIO VISUAL CONSULTANTS
ACOUSTIC DIMENSIONS
15508 WRIGHT BROTHERS DR., ADDISON, TX 75001

ULJHW
4801 SPRING VALLEY RD., DALLAS, TX 75244

CODE / FIRE PROTECTION
FSC, INC.
3225 INDIAN CREEK, SUITE 300, OVERLAND PARK, KS 66210

FOOD SERVICE
RICCA NEWMARK
5325 SOUTH VALENTIA, GREENWOOD VLG, CO 80111

WAYFINDING
SELEBY PETERSON DESIGN
432 CULVER BLVD., PLAYA DEL REY, CA 90283

VERTICAL TRANSPORTATION
ELEVATOR ADVISORY GROUP
1420 SPRINGFIELD AVE., SAINT PAUL, MN 55124

ADA CONSULTANT
ED ROTHER CONSULTING, LLC
2090 MISSOURI HILLSVIEW, LOUISBURG, KS 66303


WIND / SNOW CONSULTANT
ROWAN, WILLIAMS, DAVIES, AND IRWIN, INC.
866 WOODLAWN RD. W., QUELPHI ON CANADA N.H. 188

BUILDING ENVELOPE CONSULTANT
THORNTON TOMASETTI - BUILDING SKIN PRACTICE
330 N. WABASH AVE., SUITE 1500, CHICAGO, IL 60611

FAÇADE ACCESS CONSULTANT
LEIGH BATES, INC.
8888 LINCOLN ST., SUITE 105, LITTLETON, CO 80122



CERTIFICATION
I hereby certify that the plan, specification, or report was prepared by me or under my direct supervision and that I am a duly Licensed Professional Engineer under the laws of the State of Minnesota.
Name: Daniel E. Bremer
Reg. No.: 45518
Date: 5/02/2014
Signature: [Signature]

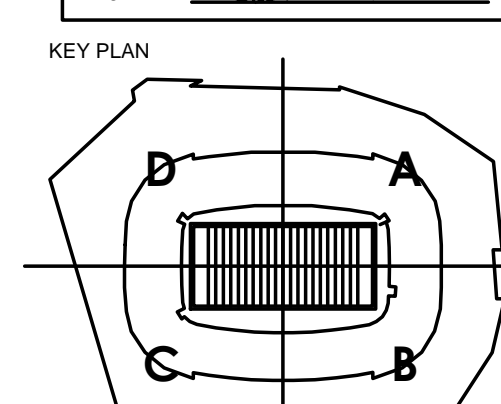

REVISION NO.	DESCRIPTION	DATE
1	CCD-060	4/20/14
2	CCD-121	8/22/14
3	AS1-172	1/20/15
4	AS1-191	3/20/15
5	AS1-256	6/28/15
6	CCD-232	10/20/15
7	CCD-248	8/7/15



HKS PROJECT NUMBER
16246.000

DATE
MAY 2, 2014

ISSUE
CCD-060

SHEET TITLE
OVERALL UTILITY PLAN

SHEET NO.
C4.00

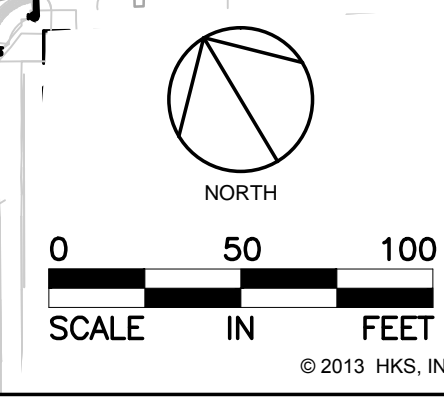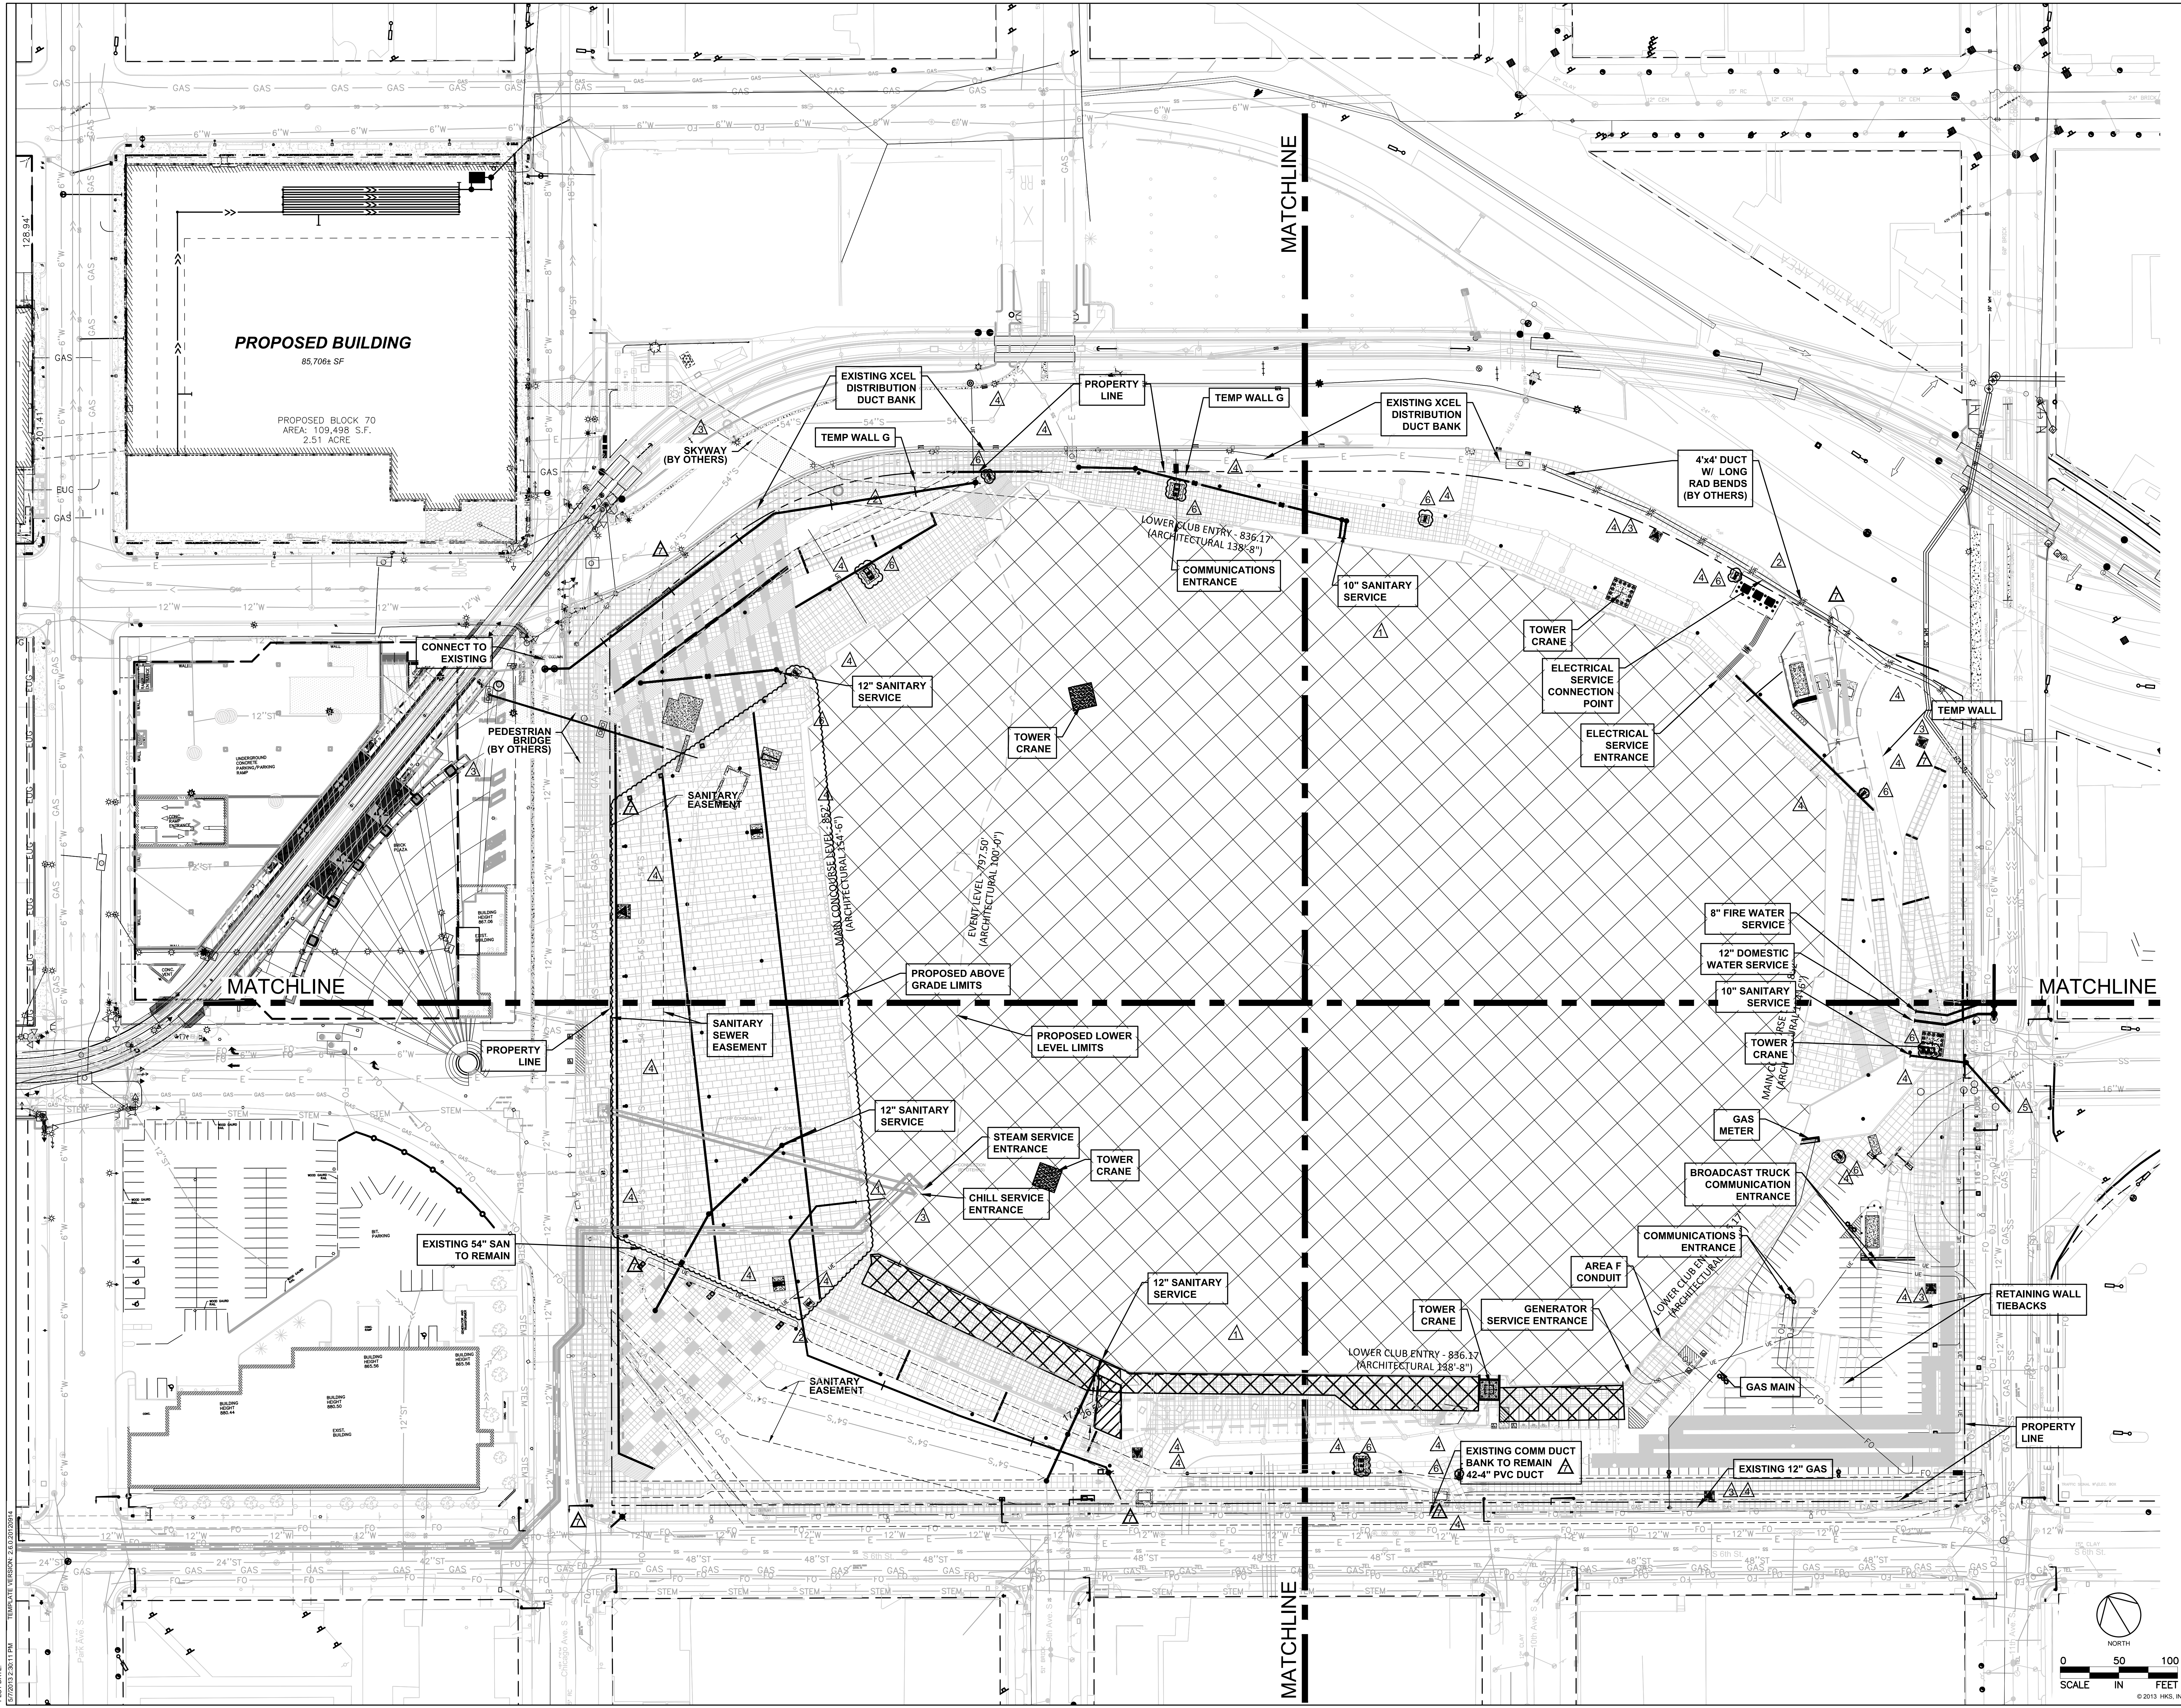

PLOT DATE:
5/2/2014 2:30:11 PM
TEMPERATURE VERSION: 2012/02/20/14